


STRUCTURE DRAWING LIST FOR DETAILED DESIGN CONSULTANCY FOR HINGNA DEPOT OF NAGPUR METRO RAIL CORPORATION, NAGPUR

| S.NO. | DRAWING TITLE | DRAWING NO. |
|--|---|-------------------------|
| BUILDING 1: TIME AND SECURITY OFFICE | | |
| 1 | TIME & SECURITY OFFICE - FRAMING PLAN | N1DDCD01-DPOH-T-ST-2101 |
| 2 | FOOTING PLAN | N1DDCD01-DPOH-T-ST-2111 |
| BUILDING 2: MAINTENANCE BUILDING | | |
| 1 | MAINTENANCE BUILDING-GROUND LEVEL FRAMING PLAN | N1DDCD01-DPOH-T-ST-2201 |
| 2 | MAINTENANCE BUILDING-MEZZANINE LEVEL FRAMING PLAN | N1DDCD01-DPOH-T-ST-2206 |
| 3 | PILE LAYOUT PLAN | N1DDCD01-DPOH-T-ST-2221 |
| BUILDING 3: ADMIN +DCC | | |
| 1 | OFFICE BUILDING - GROUND FLOOR PLAN | N1DDCD01-DPOH-T-ST-2301 |
| 2 | OFFICE BUILDING - FIRST FLOOR PLAN | N1DDCD01-DPOH-T-ST-2306 |
| 3 | PILE LAYOUT AND DETAILS | N1DDCD01-DPOH-T-ST-2321 |
| BUILDING 6: P-WAY ROOM FOR WORKSHOP TRACK MACHINE | | |
| 1 | WORK SHOP - FRAMING PLANS | N1DDCD01-DPOH-T-ST-2501 |
| 2 | PILE LAYOUT AND DETAILS | N1DDCD01-DPOH-T-ST-2521 |
| BUILDING 8:INTERNAL CLEANING | | |
| 1 | INTERNAL CLEANING SHED - FRAMING PLANS | N1DDCD01-DPOH-T-ST-2601 |
| BUILDING 9:PIT WHEEL LATHE | | |
| 1 | PIT WHEEL LATHE - FRAMING PLANS | N1DDCD01-DPOH-T-ST-2701 |

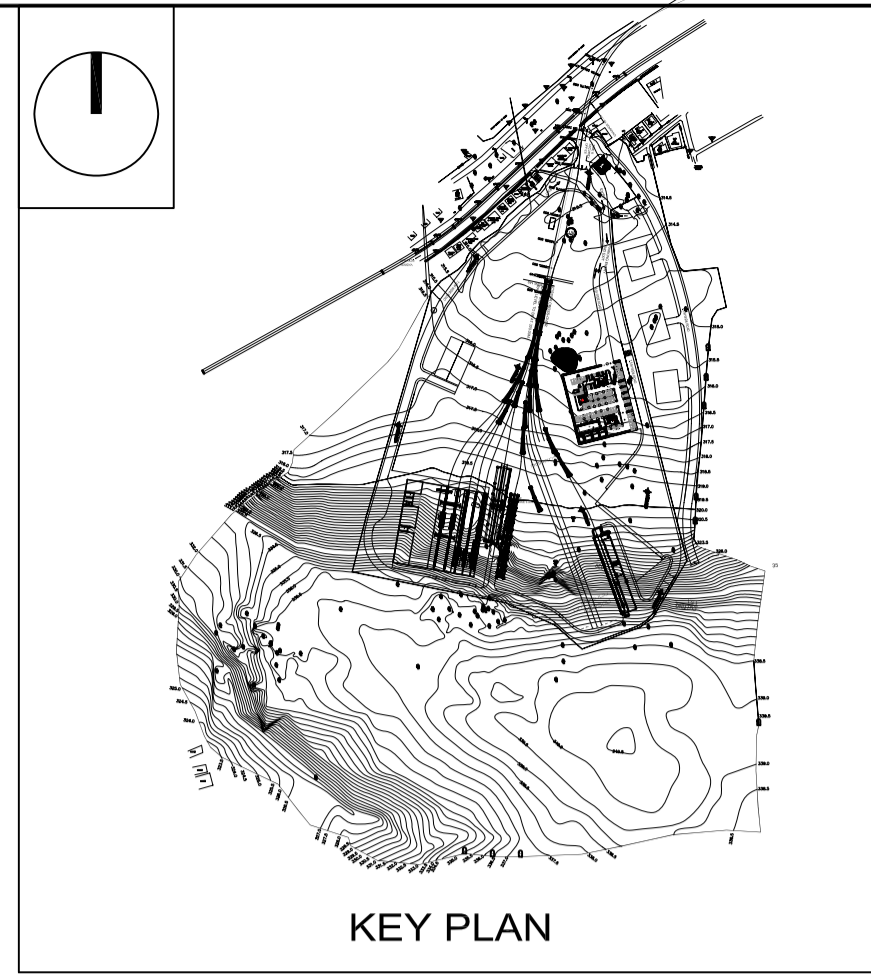

THIS DRAWING IS THE PROPERTY OF NAGPUR METRO RAIL CORPORATION LTD.

GENERAL NOTES:
 1. ALL DIMENSIONS ARE IN MILLIMETERS & LEVELS ARE IN METERS UNLESS OTHERWISE STATED.
 2. ALL DIMENSIONS ARE TO BE READ AND NOT MEASURED.
 3. ANY DISCREPANCIES MUST BE BROUGHT TO THE NOTICE OF THE DMRC BEFORE EXECUTION OF WORK AT SITE.
 4. THIS DRAWING MUST BE READ IN CONJUNCTION WITH ALL RELEVANT ARCHITECTURAL, STRUCTURAL, PLUMBING & FIRE FIGHTING, ELECTRICAL AND TRAFFIC MANAGEMENT DRAWINGS.
 5. ALL DOOR/WINDOW CILL & LINTEL LEVELS ARE MEASURED FROM MAIN FLOOR FINISHED LEVELS.

| REVISIONS | | | | | |
|-----------|-------------|------|------|------|------|
| REV | DESCRIPTION | DRN. | CHD. | VER. | DATE |
| | | | | | |

| APPROVAL BY NMRCL | | | |
|-------------------|--------------|--------------|--------------|
| ARCHITECTURE | AM/Mgr | DY CA-III | CA |
| STRUCTURE | AM/Design | DY CE/DESIGN | ED/Technical |
| ELECTRICAL | AEM/E&M | DGM/E | CEE/UD |
| CIVIL | AGM/Civil | CE/General | |
| | AGM/Tele | CSTE | |
| | Fire Officer | | |

Certified that this document has been designed and checked in accordance with DDC Quality Assurance Plan.

OFFICE OF DRAWING ORIGIN:
FOUNTAINHEAD
 ARCHITECTURE INTERIOR & LANDSCAPE
 C-9/9148, VASANT KUNJ, NEW DELHI
 PH: 011-26891534, 26124540, 26124543. FAX: 26898459
 Email: office@studiofountainhead.com

Authorised Signatory for DDC.
 N1DDC D-01 Project Manager

CONSULTANTS:

| | |
|--|-----------------|
| Metro House, 28/2, Anand Nagar, C K Naidu Road, Civil Lines, Nagpur - 440001 | |
| N1DDC D-01 | |
| ROLLING STOCK DEPOT AT HINGNA | |
| DRAWING TITLE: STRUCTURE DRAWING LIST | |
| DRAWING NO: N1DDCD01-DPOH-T-ST-1001 | |
| DATE: 06.08.2016 | SCALE: NTS |
| DRAWN BY: ALPANA | CHECKED BY: S.M |
| STATUS: FOR TENDER | REV: R0 |
| VERIFIED BY: S.M | |

STRUCTURAL

This drawing must not be either loaned, copied or otherwise reproduced in whole or in part or used for any purpose without the prior written permission of DMRC.