


FIRST FLOOR LVL. FRAMING PLAN
 NOTE:- ALL COLUMN SIZE ARE (600X1000) UNLESS NOTED OTHERWISE
 C1 = 1500X1500

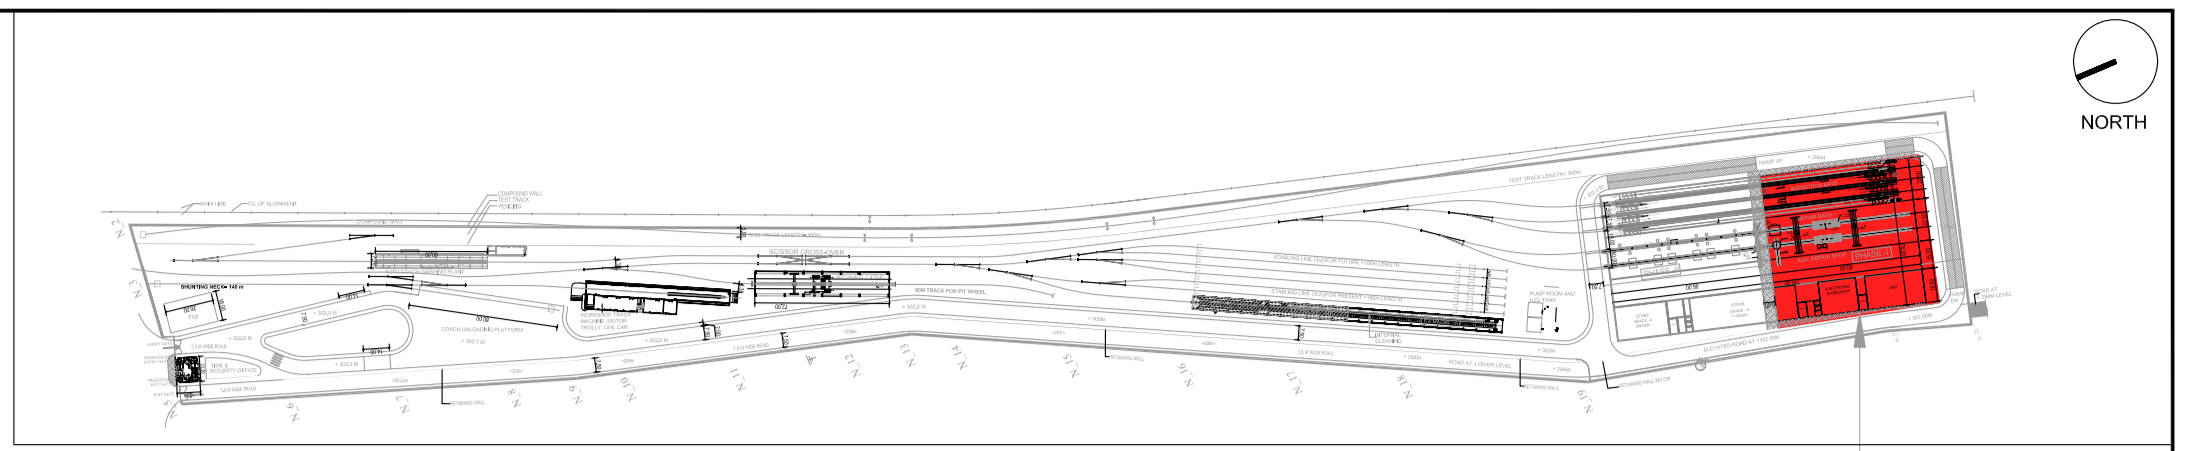

MAIN BUILDING

NOTE:-
 * ALL COLUMN & BEAMS SIZES ARE TENTATIVE
 * ALL LEVEL SHOULD BE CONFIRM WITH ARCH. DRGS.

BEAM SCHEDULE	
BEAM MARKED	BEAM SIZE
B1,B2	(450X1000)
B3	(300X1000)
B6	(600X1500)
B7	(1500X1500)
LB1,B4	(300X600)

THIS DRAWING IS THE PROPERTY OF NAGPUR METRO RAIL CORPORATION LTD.

GENERAL NOTES:
 1. ALL DIMENSIONS ARE IN MILLIMETERS & LEVELS ARE IN METERS UNLESS OTHERWISE STATED.
 2. ALL DIMENSIONS ARE TO BE READ AND NOT MEASURED.
 3. ANY DISCREPANCIES MUST BE BROUGHT TO THE NOTICE OF THE DMRC BEFORE EXECUTION OF WORK AT SITE.
 4. THIS DRAWING MUST BE READ IN CONJUNCTION WITH ALL RELEVANT ARCHITECTURAL, STRUCTURAL, PLUMBING & FIRE FIGHTING, ELECTRICAL AND TRAFFIC MANAGEMENT DRAWINGS.
 5. ALL DOOR/WINDOW CILL & LINTEL LEVELS ARE MEASURED FROM MAIN FLOOR FINISHED LEVELS.

REFERENCE DRAWINGS	
Dwg. No.	Description

REVISIONS					
REV	DESCRIPTION	DRN.	CHD.	VER.	DATE

APPROVAL BY NMRCL			
ARCHITECTURE	AM/Mgr	DY CA-III	CA
STRUCTURE	AM/Design	DY CE/DESIGN	ED/Technical
ELECTRICAL	AEME&M	DG/ME	CEE/UD
CIVIL	AGM/Civil	CE/General	
	AGM/Tele	CSTE	
	Fire Officer		

Certified that this document has been designed and checked in accordance with DDC Quality Assurance Plan.

Authorised Signatory for DDC.
 N1DDC D-01 Project Manager

OFFICE OF DRAWING ORIGIN:
FOUNTAINHEAD
 ARCHITECTURE INTERIOR & LANDSCAPE
 C-9/9148, VASANT KUNJ, NEW DELHI
 PH: 011-26891534, 26124540, 26124543. FAX: 26898459
 Email: office@studiofountainhead.com

STRUCTURAL CONSULTANT :
LKT Engineering Consultants Ltd.
 63/12A, 11th floor, Main Rama road, Najafgarh road, industrial area, opposite Kirti nagar Metro Station, New Delhi-110015, Phone:- 011-4556814-18
 info@lktengineering.com
 http://www.lktengineering.com

NAGPUR METRO RAIL CORPORATION LTD.
 Metro House, 28/2, Anand Nagar, C K Naidu Road, Civil Lines, Nagpur - 440001

N1DDC D-01

ROLLING STOCK DEPOT AT MIHAN

DRAWING TITLE: MAIN BUILDING- FIRST FLOOR FRAMING PLAN
 DRAWING NO: N1DDC01-DPOM-T-ST-2211
 DATE: 06.07.2016
 SCALE: 1:200
 STATUS: FOR TENDER
 DRAWN BY: SOMDUTT
 CHECKED BY: H.S.
 VERIFIED BY: L.K.TYAGI

REV: R0

STRUCTURAL

This drawing must not be either loaned, copied or otherwise reproduced in whole or in part or used for any purpose without the prior written permission of DMRC.