
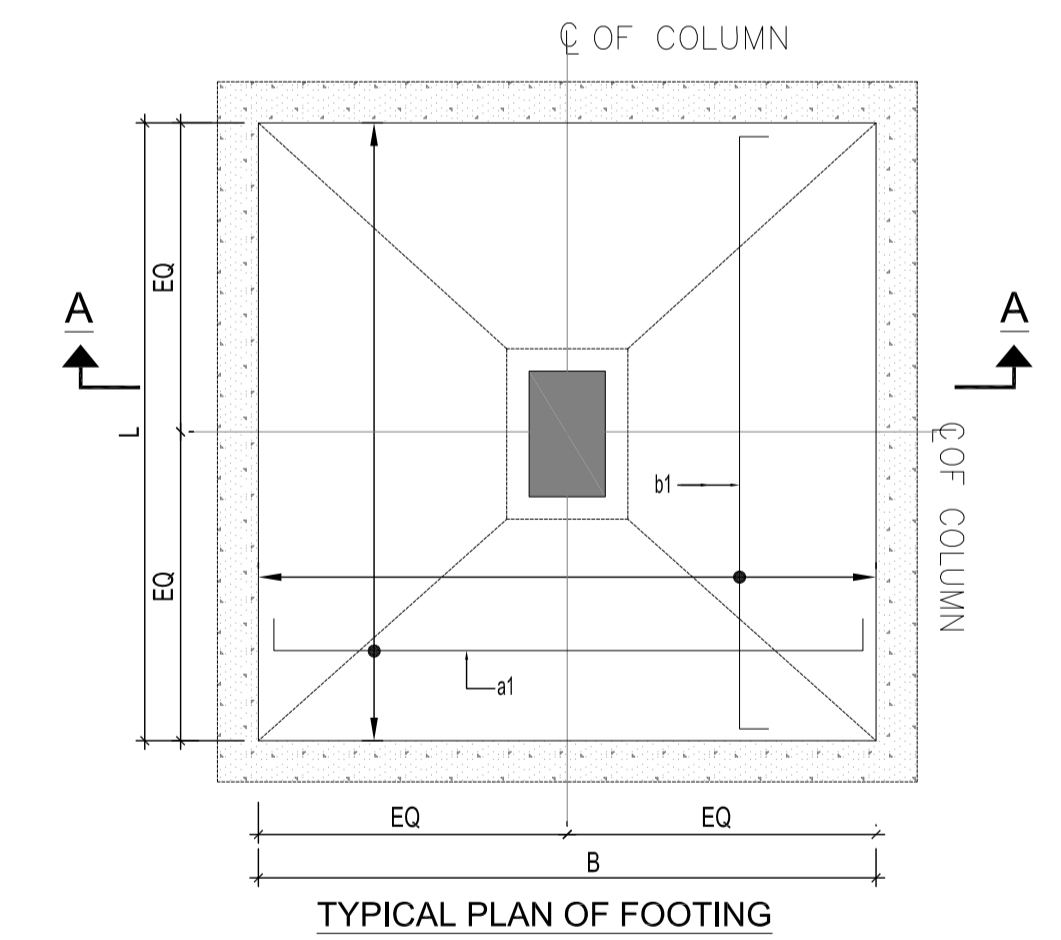


FOUNDATION REINFORCEMENT SCHEDULE:-

SL.NO.	FOOTING	FOOTING SIZE	DEPTH		REINFORCEMENT (BOTTOM)		REINFORCEMENT (TOP)
		(LxW)	(D)	(d)	(a1)	(b1)	-----
1.	F1	3500x3500	600	200	10Ø@125 C/C	10Ø@125 C/C	-----

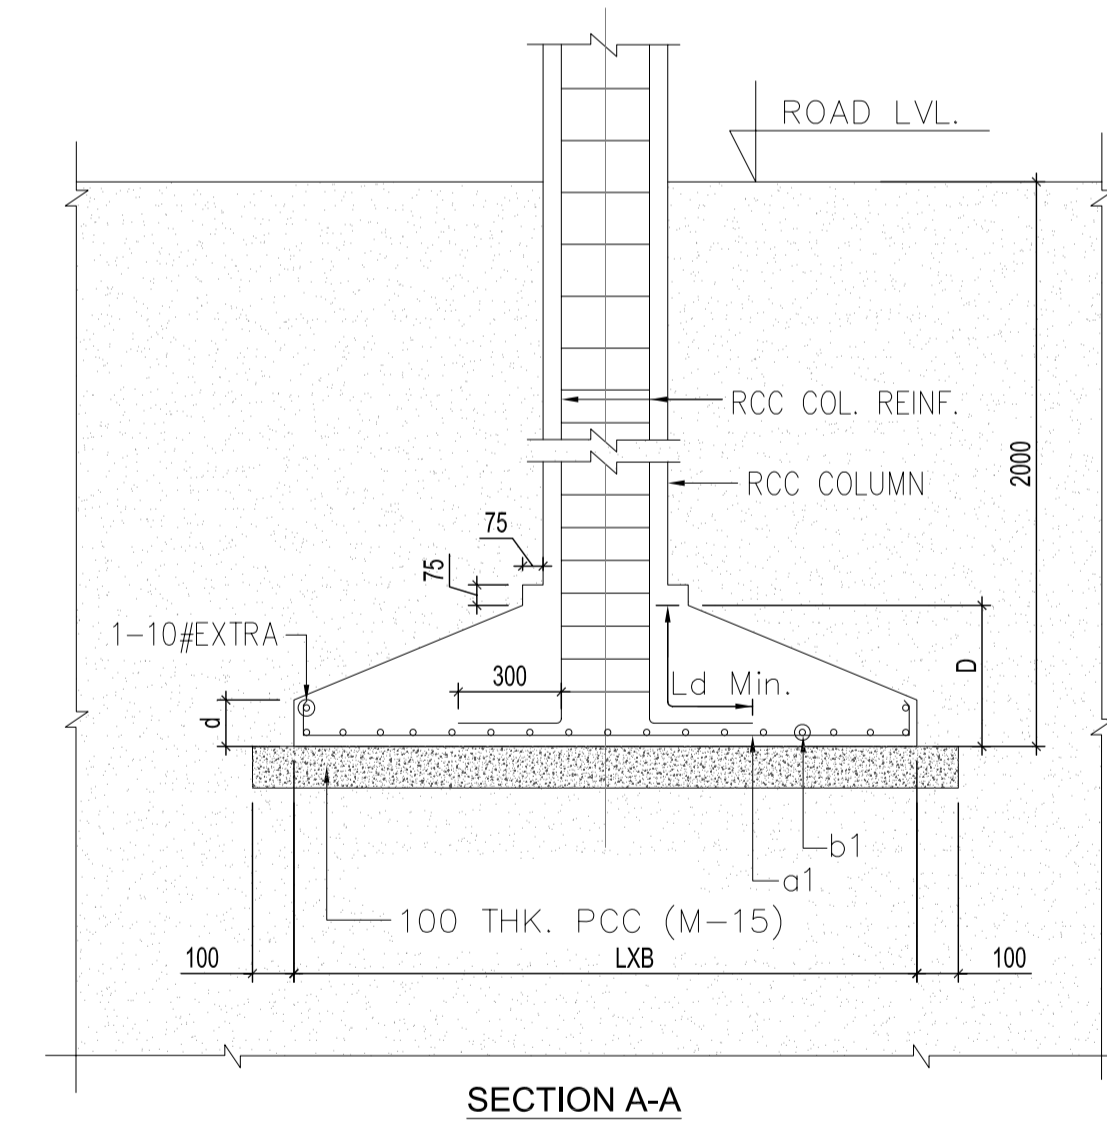

FOOTING LAYOUT PLAN

NOTE:- ALL COLUMN SIZE ARE (450X600)

ALL COLUMN & BEAMS SIZES ARE TENTATIVE

ALL LEVEL SHOULD CONFIRM WITH ARCH. DRGS.

- GENERAL NOTES:**
1. ALL DIMENSIONS ARE IN MILLIMETERS & LEVELS ARE IN METERS UNLESS OTHERWISE STATED.
 2. ALL DIMENSIONS ARE TO BE READ AND NOT MEASURED.
 3. ANY DISCREPANCIES MUST BE BROUGHT TO THE NOTICE OF THE DMRC BEFORE EXECUTION OF WORK AT SITE.
 4. THIS DRAWING MUST BE READ IN CONJUNCTION WITH ALL RELEVANT ARCHITECTURAL, STRUCTURAL, PLUMBING & FIRE FIGHTING, ELECTRICAL AND TRAFFIC MANAGEMENT DRAWINGS.
 5. ALL DOOR/WINDOW CILL & LINTEL LEVELS ARE MEASURED FROM MAIN FLOOR FINISHED LEVELS.

REFERENCE DRAWINGS	
Dwg. No.	Description

REVISIONS					
REV	DESCRIPTION	DRN.	CHD.	VER.	DATE

APPROVAL BY NMRCL			
ARCHITECTURE	AM/Mgr	DY CA-III	CA
STRUCTURE	AM/Design	DY CE/DESIGN	ED/Technical
ELECTRICAL	AEME&M	DGM/E	CEE/UD
CIVIL	AGM/Civil	CE/General	
	AGM/Tele	CSTE	
	Fire Officer		

Certified that this document has been designed and checked in accordance with DDC Quality Assurance Plan.

OFFICE OF DRAWING ORIGIN:
FOUNTAINHEAD
 ARCHITECTURE INTERIOR & LANDSCAPE
 C-9/9148, VASANT KUNJ, NEW DELHI
 PH: 011-26891534, 26124540, 26124543. FAX: 26898459
 Email: office@studiofountainhead.com

Authorised Signatory for DDC.
 N1DDC D-01 Project Manager

STRUCTURAL CONSULTANT :
LKT Engineering Consultants Ltd.
 63/12A, 1st floor, Main Rama road, Najafgarh road, industrial area, opposite Kirti nagar Metro Station, New Delhi-110015, Phone: + 011-4556814-18 info@lktengineering.com http://www.lktengineering.com

NAGPUR METRO RAIL CORPORATION LTD.
 Metro House, 28/2, Anand Nagar, C K Naidu Road, Civil Lines, Nagpur - 440001

N1DDC D-01			
ROLLING STOCK DEPOT AT HINGNA			
DRAWING TITLE: TIME & SECURITY OFFICE- FOOTING PLAN			
DRAWING NO: N1DDCD01-DPOH-T-ST-2111			REV: R0
DATE: 08.07.2016	SCALE: 1:200	STATUS: FOR TENDER	
DRAWN BY: HIMANSHU TYAGI	CHECKED BY: H.S	VERIFIED BY: L.K.TYAGI	

This drawing must not be either loaned, copied or otherwise reproduced in whole or in part or used for any purpose without the prior written permission of DMRC.

THIS DRAWING IS THE PROPERTY OF NAGPUR METRO RAIL CORPORATION LTD.

STRUCTURAL